


**GREASE TRAP**  
NO SCALE


DRAIN SCHEDULE	
SYMBOL	DESCRIPTION
RD-1	MADE #4-3500 CAST IRON ROOF DRAIN WITH FLANGE, FLASHING RING W/ GRAVEL STOP, CE DOME STRAINER AND CLAMPING COLLAR.
FD-1	MADE #4-1100 CAST IRON FLOOR DRAIN WITH SEWAGE FLANGE, CLAMPING COLLAR AND ADJUSTABLE NICKEL BRASS STRAINER.
FD-2	SAME AS FD-1 EXCEPT WITH POLISHED BRASS STRAINER AND TYPE EF BRASS FUNNEL.
FD-3	MADE #4-1660 CAST IRON FLOOR DRAIN W/ FLANGE, SEWAGE CLEANINGS, SEDIMENT BUCKET AND POLISHED BRASS GRATE.
FD-4	SAME AS FD-3 EXCEPT W/ TYPE EF POLISHED BRASS FUNNEL.
FD-5	MADE #4-2570 CAST IRON FLOOR DRAIN W/ SEDIMENT BUCKET AND SLOTTED COARSE SET GRATE.

LEGEND	
SYMBOL	DESCRIPTION
---	SOIL OR WASTE
---	VENT
---	HOT WATER
---	COLD WATER
---	HOT WATER RETURN
—RL—	RAINLEADER
—SD—	STORM DRAIN
FD	FLOOR DRAIN
RD	ROOF DRAIN
NFHH	NON-FREEZE WALL HYDRANT
VTR	VENT THRU ROOF
CO	CLEANOUT
COTF	CLEANOUT THRU FLOOR
COTW	CLEANOUT THRU WALL
COTG	CLEANOUT THRU GRADE
○	RISER NUMBER

PLUMBING		FIXTURE			SCHEDULE		REMARKS
SYMBOL	DESCRIPTION	SOIL	WASTE	VENT	HW	CW	
P-1	WATER CLOSET	4"	---	2"	---	1"	FLOOR AND FLUSH VALVE
P-2	WATER CLOSET	4"	---	2"	---	1"	FLUSH VALVE (JUNIOR)
P-3	WATER CLOSET	4"	---	2"	---	1"	FLUSH VALVE (HANDICAPPED)
P-4	URINAL	2"	---	1 1/2"	---	3/4"	WALL HUNG, FLUSH VALVE
P-5	WASHFOUNTAIN	---	2"	1 1/2"	1"	1"	36" SEAT-CIRCULAR
P-6	LAVATORY	---	2"	1 1/2"	1 1/2"	1/2"	WALL HUNG
P-7	LAVATORY	---	2"	1 1/2"	1 1/2"	1/2"	WALL HUNG (CHILD CARE)
P-8	LAVATORY	---	2"	1 1/2"	1 1/2"	1/2"	WALL HUNG (KITCHEN)
P-9	LAVATORY	---	2"	1 1/2"	1 1/2"	1/2"	COUNTER TOP
P-10	SINK	---	2"	1 1/2"	1 1/2"	1/2"	1-COMP, STAINLESS STEEL
P-11	SINK	---	2"	1 1/2"	1 1/2"	1/2"	2-COMP, STAINLESS STEEL
P-12	SERVICE SINK	---	3"	1 1/2"	1 1/2"	1/2"	FLOOR RECEPTOR
P-13	DRINKING FOUNTAIN	---	2"	1 1/2"	---	1/2"	WALL HUNG ELEC.
P-14	DRINKING FOUNTAIN	---	2"	1 1/2"	---	1/2"	HANDICAPPED
P-15	CAN WASH	---	---	---	1/2"	1/2"	AIMING VALVE
P-16	SHOWER	---	---	---	1/2"	1/2"	AIMING VALVE

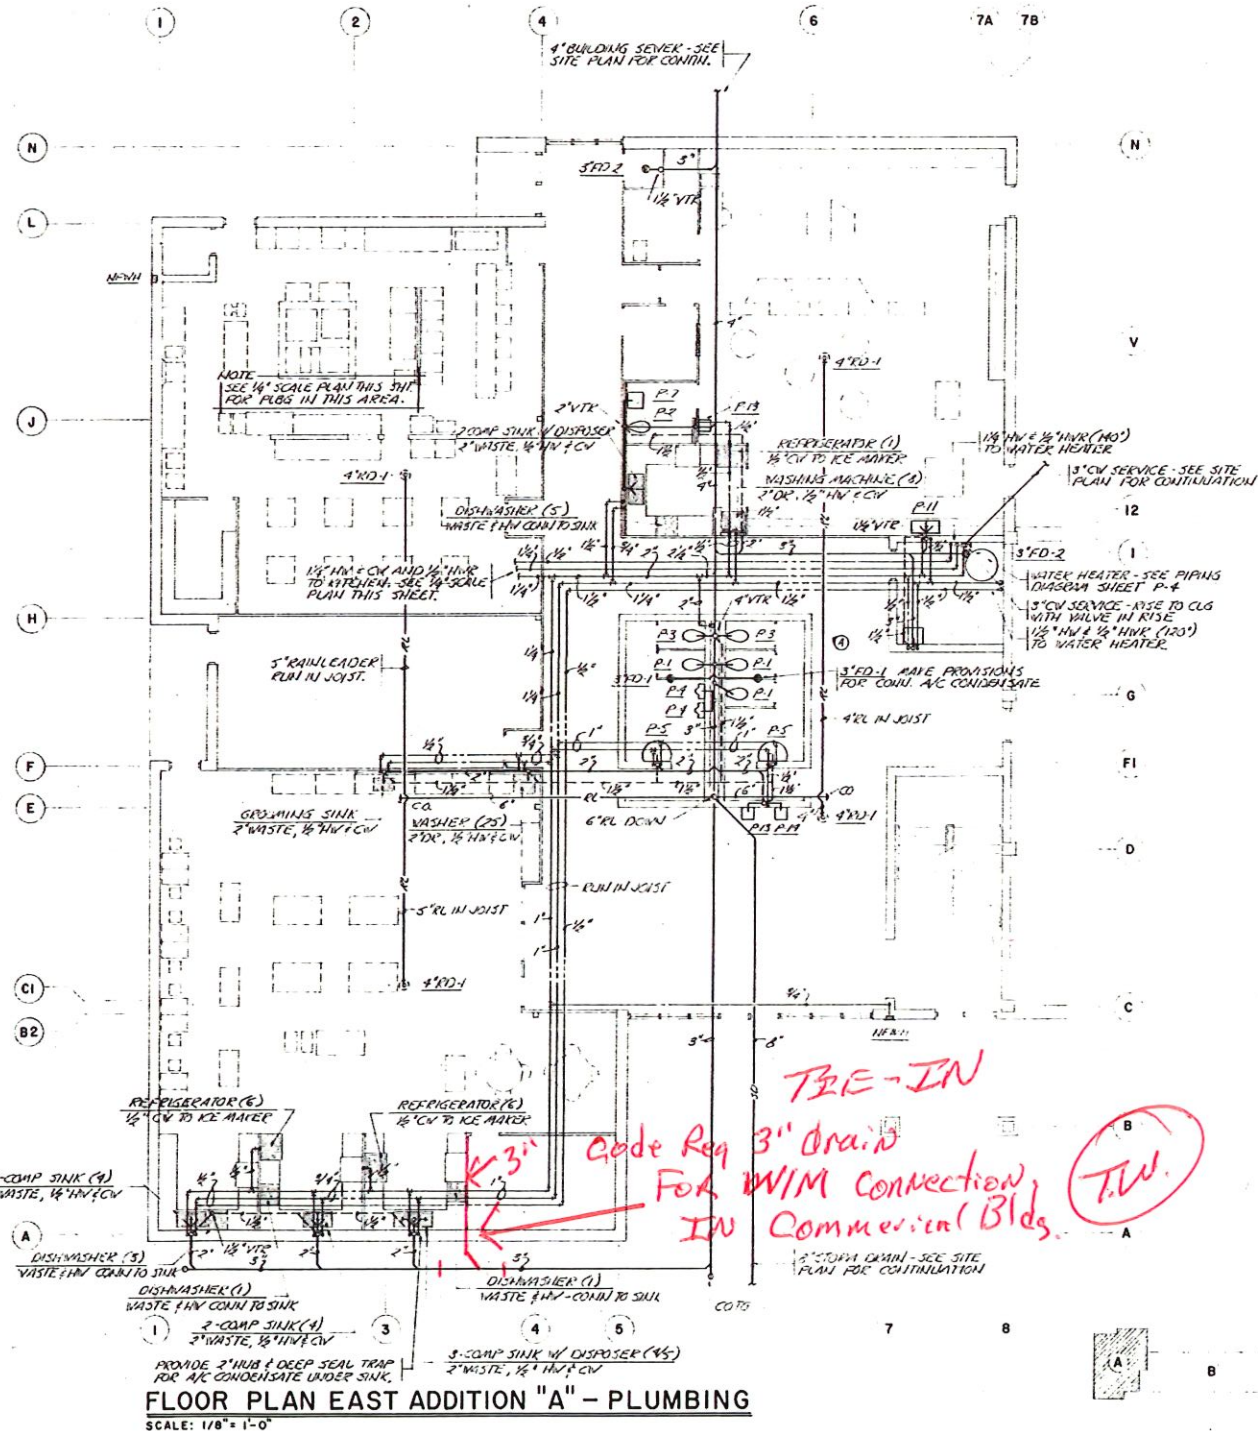

**FLOOR PLAN EAST ADDITION "A" - PLUMBING**  
SCALE: 1/8" = 1'-0"

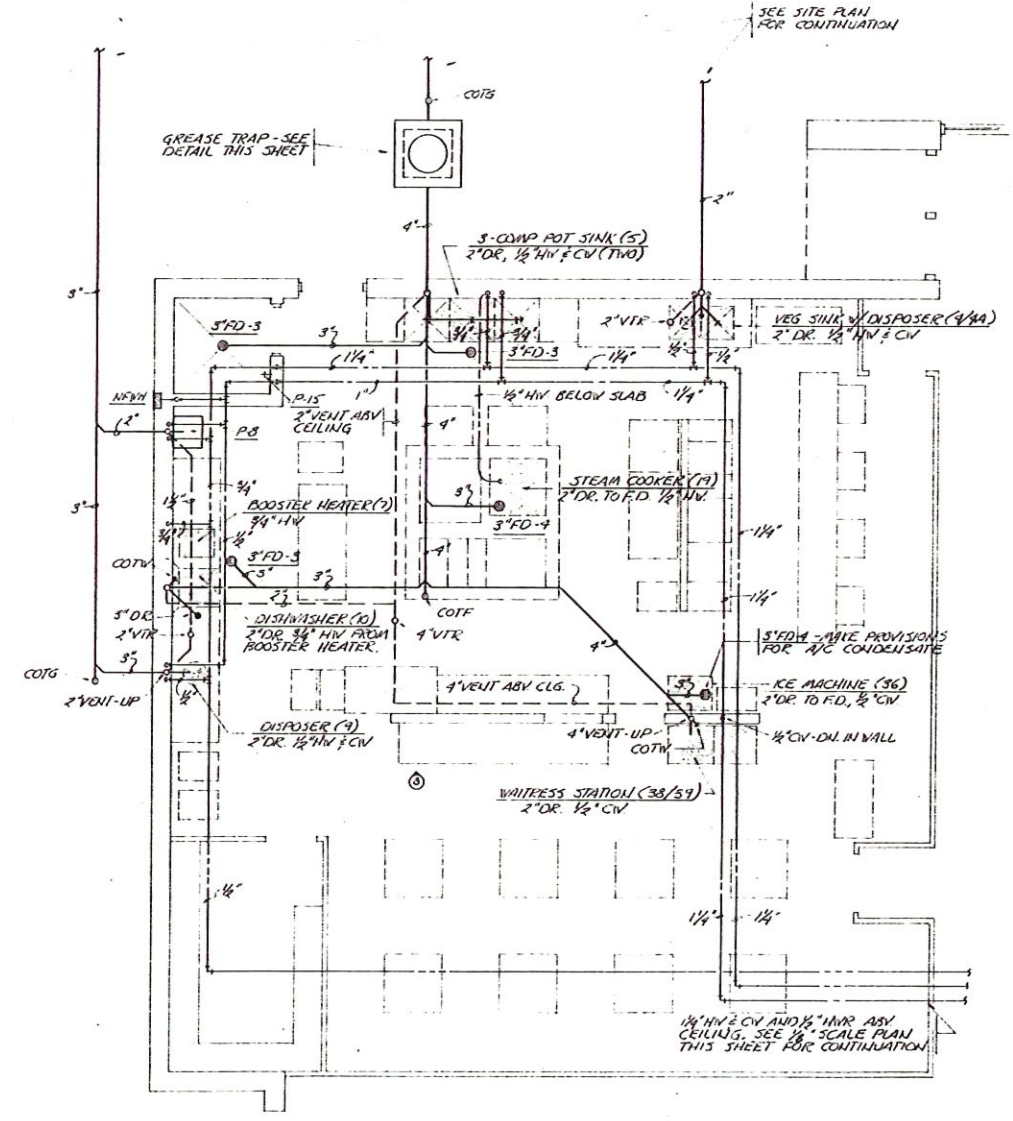

**KITCHEN PLAN - PLUMBING**  
SCALE: 1/4" = 1'-0"

NOTE:  
THE PLUMBING CONTRACTOR SHALL COORDINATE WITH EQUIPMENT VENDORS FOR EXACT LOCATION AND REQUIREMENTS OF ALL EQUIPMENT FOR EQUIPMENT FURNISHED BY OTHERS (CHILLED WATER). THE PLUMBING CONTRACTOR SHALL PROVIDE REVISIONS AND MAKE ALL NECESSARY FINAL CONNECTIONS FOR THIS EQUIPMENT AS RECOMMENDED BY MFG.